


DESCRIPTION:
 SPRINKLER RISER DETAIL (WET)

REVISIONS:
 1-25-2010

DATE:

DRAWING NO.
 FP-4B

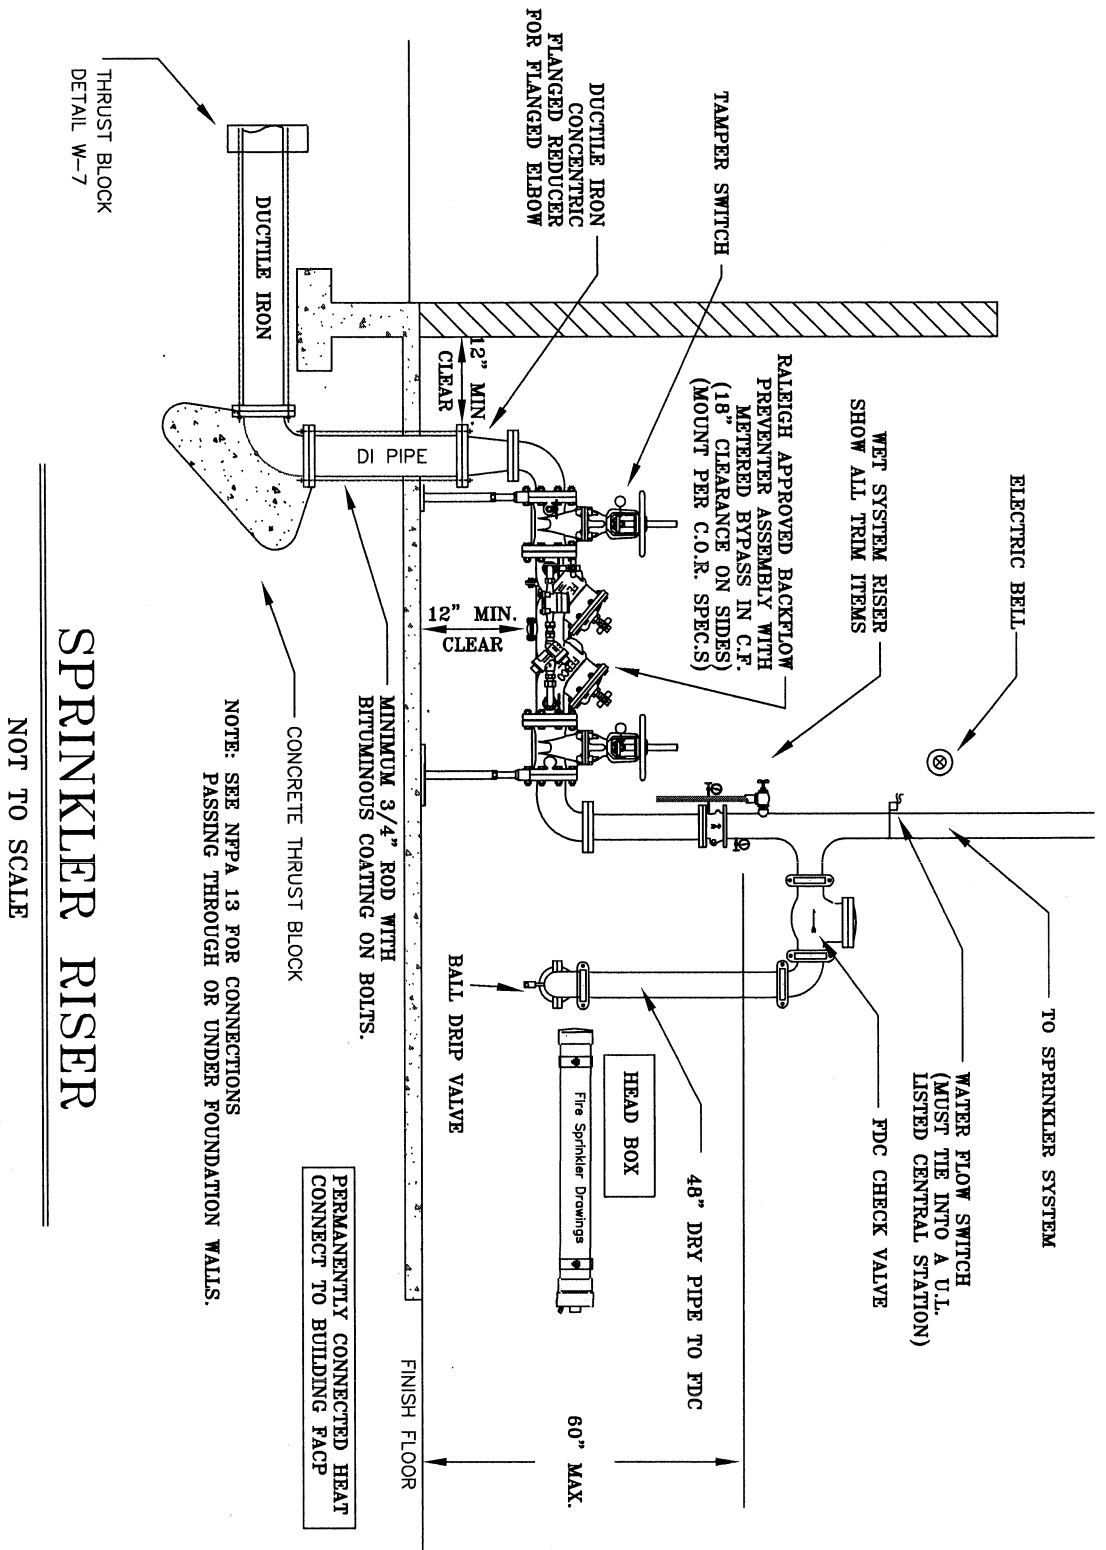

SPRINKLER RISER


NOT TO SCALE

DESCRIPTION:
 SPRINKLER RISER DETAIL (DRY)

REVISIONS:
 5-1-06

DATE:

DRAWING NO.
 FP-4A

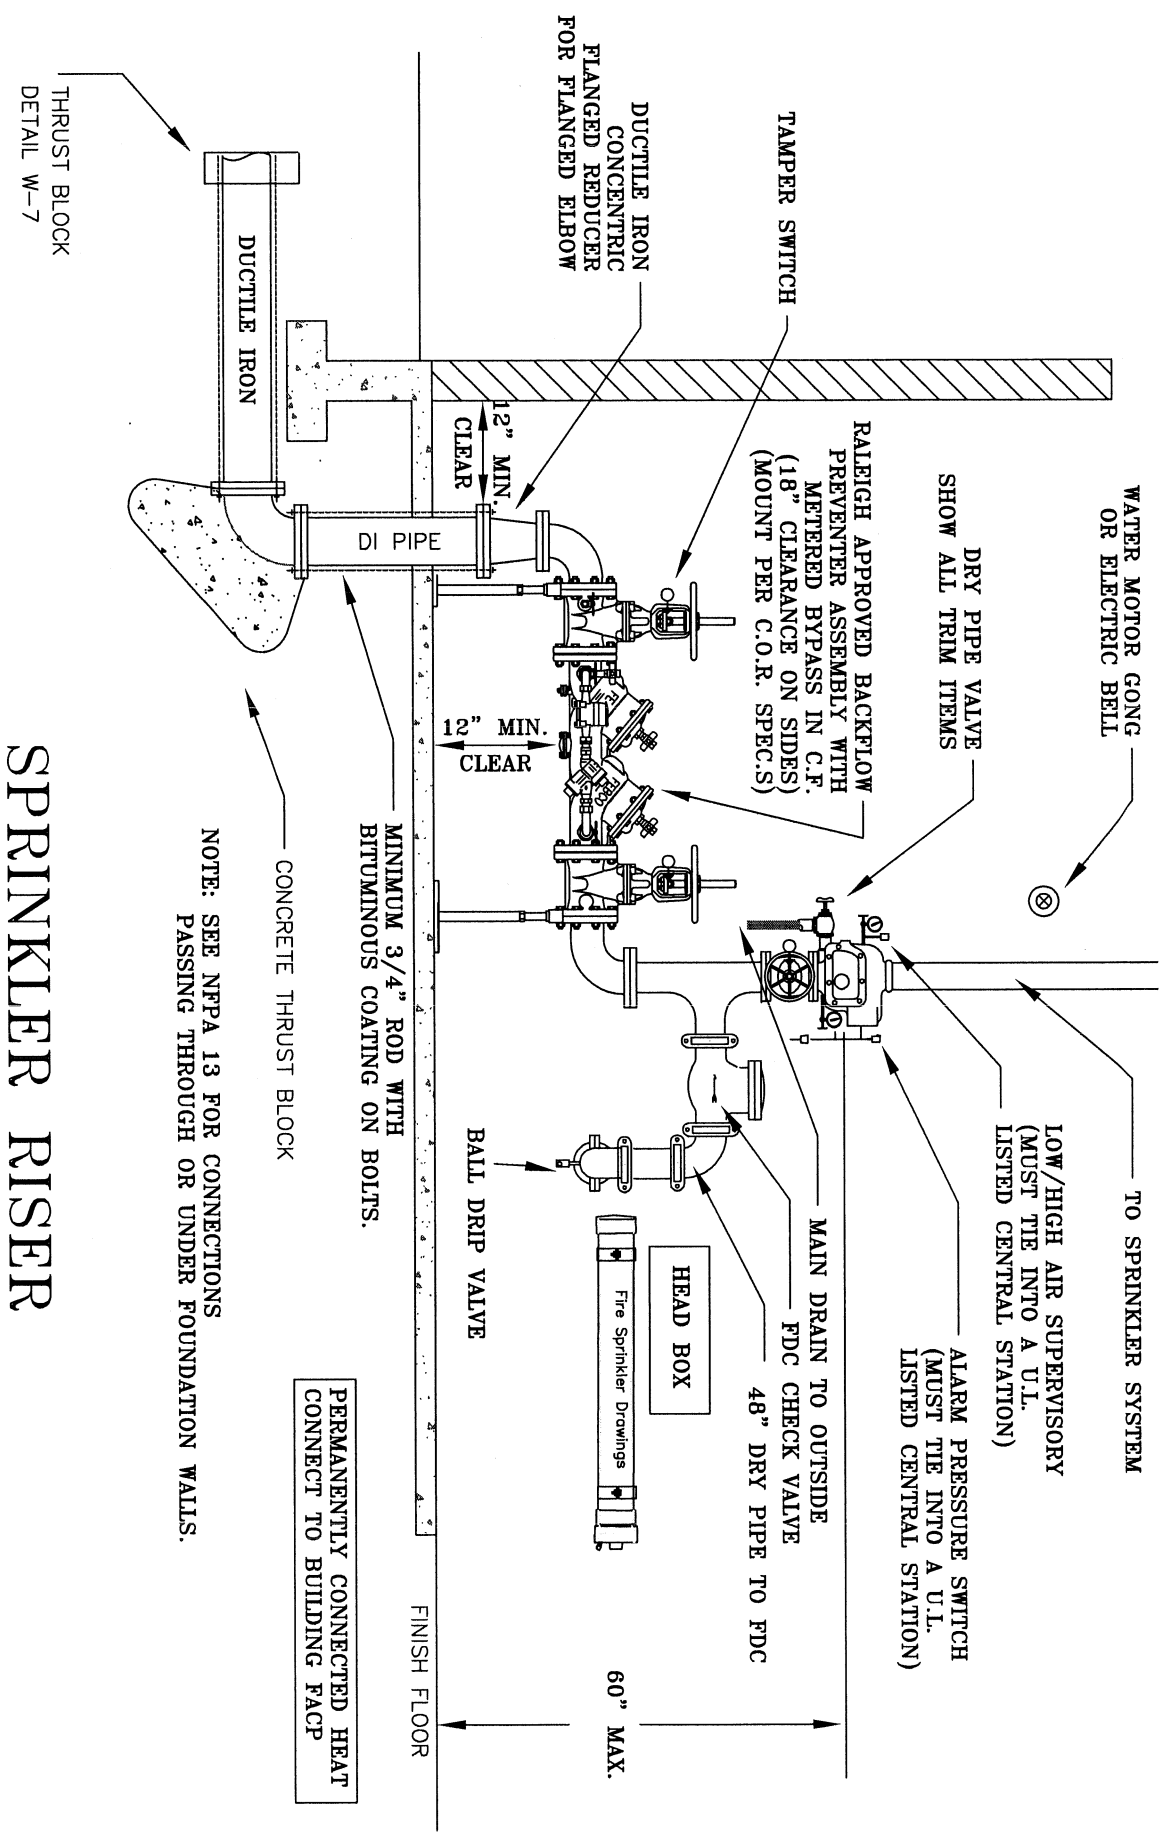

SPRINKLER RISER

NOT TO SCALE

NOTE: SEE NFPA 13 FOR CONNECTIONS PASSING THROUGH OR UNDER FOUNDATION WALLS.